 

 








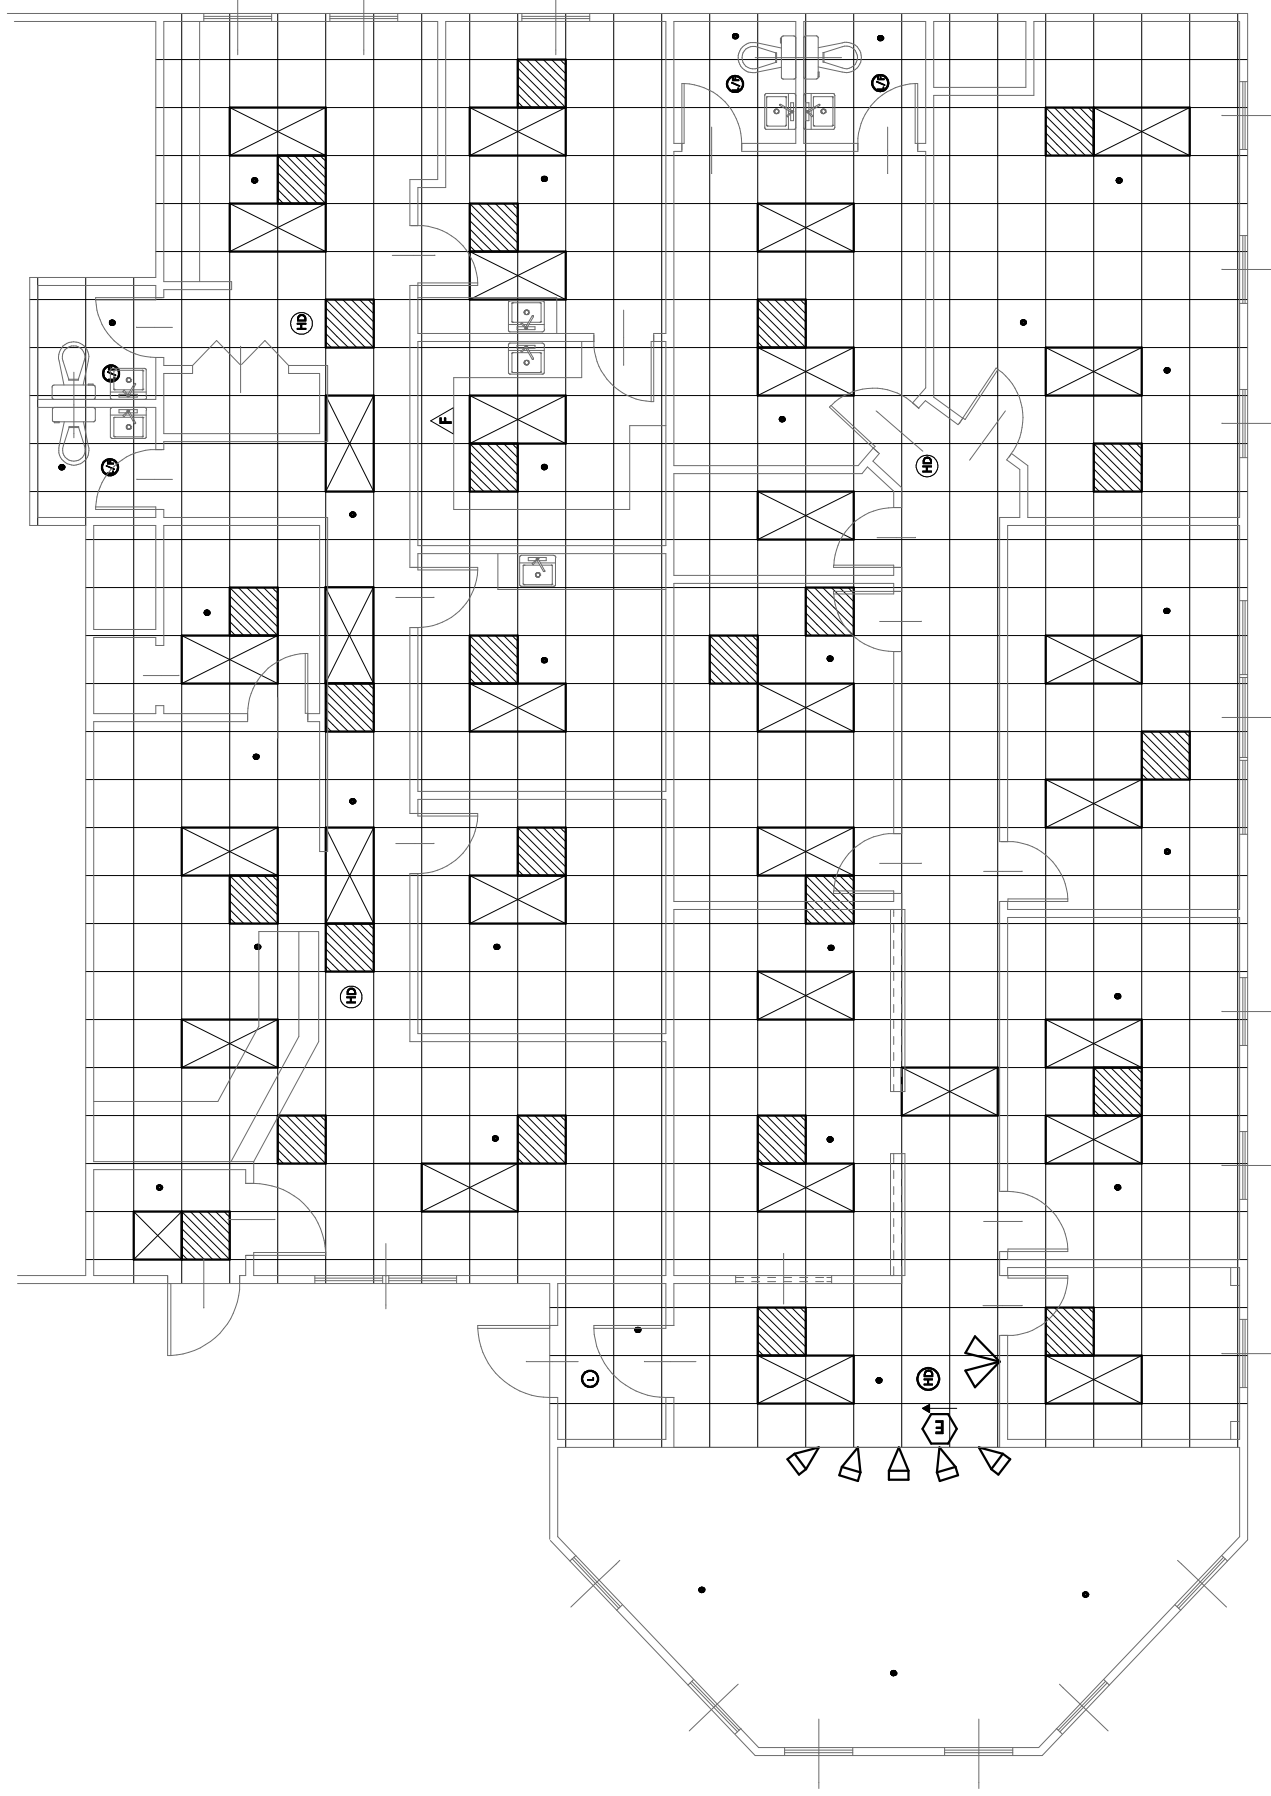


**Notes:**  
This drawing is only to be used as reference and provides approximate locations of proposed fixtures.

Any changes to the layout is the responsibility of the engineers.

-  4' x 2' Light
-  2' x 2' Light
-  Vent
-  Exit - w/directions
-  Heat Detector
-  Light / Exhaust Fan Combo
-  Light
-  Track Lighting
-  Sprinkler Head
-  Double low voltage emergency head
-  Exhaust Fan



**EXISTING LIGHTING,  
VENTING & SPRINKLER LAYOUT**

Note:  
Scale is at 1/2 shown  
on 11" x 17" prints.

EXISTING  
LAYOUT FOR  
SOUTHEAST ORTHODONTICS  
EXISTING LIGHTING,  
VENTING & SPRINKLER LAYOUT

SCALE: NOTED

DATE: FEBRUARY 2006

DRAWN BY: D PACKERT

PLAN NO. #D10762

SHEET 2 OF

**PACKERT**  
DESIGN  
CUSTOM  
HOME DESIGN  
(508) 699-0802  
www.packertdesign.com

**D2**

Note:  
Packert Design is a residence design service and not an architectural or engineering firm. These plans are intended for dimensional and conceptual use. Any engineering required is the sole responsibility of the customer and/or builder.