

Note:
Scale is at 1/2 shown
on 11" x 17" prints.












Interior Design Provided By:
ROSSORTHODONTIC
ORTHODONTIC
P.O. BOX 882, MIDLOTHIAN, TEXAS, 76065
PH: 1-972-775-8757 FX: 1-972-775-8758
ROSSORTHODONT.NET


EXISTING
LAYOUT FOR
SOUTHEAST ORTHODONTICS
PROPOSED LIGHTING,
VENTING & SPRINKLER LAYOUT

SCALE: NOTED
DATE: OCTOBER 2006
DRAWN BY: D PACKERT
PLAN NO. #D10802
SHEET 6 OF

PACKERT
CUSTOM
HOME DESIGN
(508) 699-0802
www.packertdesign.com

D6

-  4' x 2' Light
-  2' x 2' Light
-  Vent
-  Exit - w/directions
-  Heat Detector
-  Light / Exhaust Fan Combo
-  Light
-  Track Lighting
-  Sprinkler Head
-  Double low voltage emergency head
-  Exhaust Fan

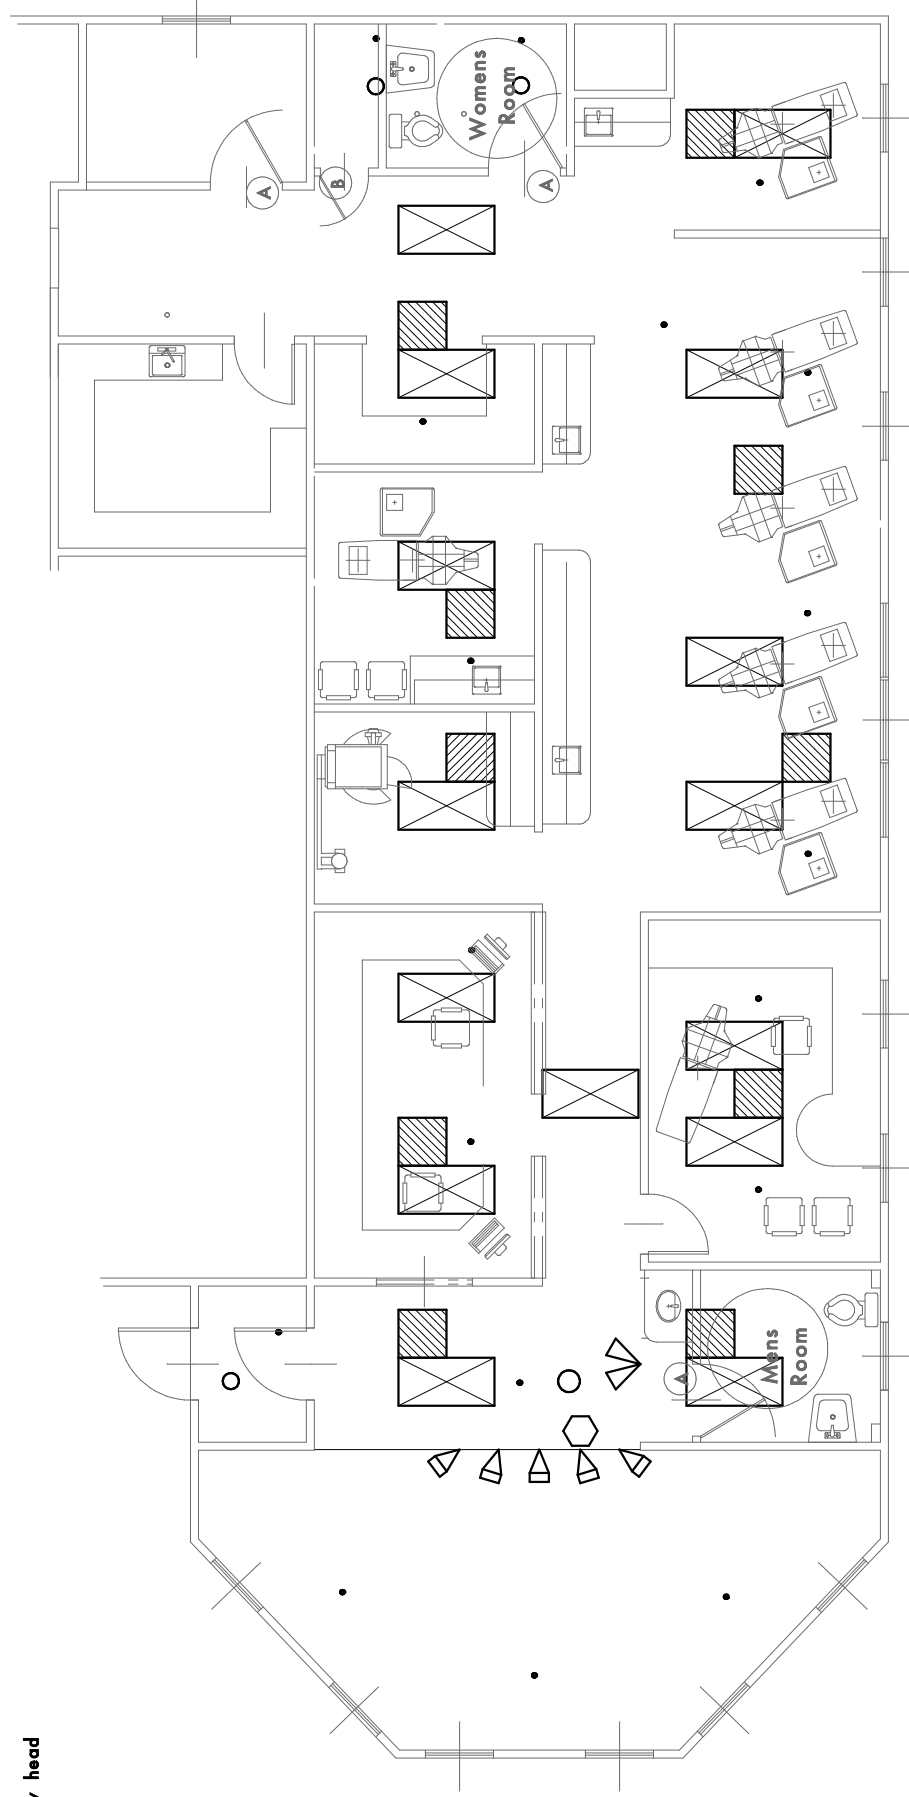

Proposed Layout

LEGEND:
UNLESS OTHERWISE NOTED
EXISTING: _____
EXISTING (TO BE REMOVED): - - - - -
PROPOSED: _____

Note:
Packert Design is a residence design service and not an architectural or engineering firm. These plans are intended for dimensional and conceptual use. Any engineering required is the sole responsibility of the customer and/or builder.